

- NOTES:
- DO NOT SCALE FROM DWGS.
  - CONTRACTOR TO VERIFY ALL DIMENSIONS ON SITE AND REPORT ANY DISCREPANCIES TO THE ENGINEER.
  - ALL WORK TO BE PERFORMED IN ACCORDANCE WITH THE DEPARTMENT OF TRANSPORTATION AND WORKS' SPECIFICATIONS AND THE DEPARTMENT OF GOVERNMENTAL SERVICES PRIVATE SEWAGE DISPOSAL AND WATER SUPPLY STANDARDS.
  - CONTRACTOR IS RESPONSIBLE FOR OBTAINING ALL REQUIRED PERMITS TO COMPLETE THE WORK.
  - DRAWINGS C1, C2 AND C3 INDICATE A TYPICAL SITE LAYOUT AND DETAILS ONLY. ACTUAL SITE LOCATION, TOPOGRAPHICAL SURVEYS AND GEOTECHNICAL REPORTS TO BE PROVIDED BY THE DEPARTMENT OF TRANSPORTATION AND WORKS. SITE DESIGN, INCLUDING LAYOUT, GRADING AND THE SEWAGE DISPOSAL SYSTEM TO BE REVISED BY THE ENGINEER TO SUIT ACTUAL SITE LOCATION AND CONDITIONS.
  - GRUBBING AND ROUGH GRADING OF ROCK MAT OVER ENTIRE SITE TO BE PERFORMED BY OTHERS. CONTRACTOR SHALL BRING SITE TO FINISHED GRADES BY SUPPLYING AND PLACING 100mm MAINTENANCE GRADE III MATERIAL EXCEPT IN LOCATION OF SEPTIC FIELD. CONTRACTOR SHALL PLACE 100mm TOPSOIL AND SEED OVER ENTIRE AREA OF SEPTIC FIELD, EXTENDING 4.5m BEYOND FIELD ON ALL SIDES.
  - FINAL FOUNDATION DESIGN TO BE COMPLETED BASED ON GEOTECHNICAL REPORTS PROVIDED BY THE DEPARTMENT OF TRANSPORTATION AND WORKS. REFER TO STRUCTURAL DRAWINGS FOR DETAILS.
  - CONTRACTOR TO COMPLETE PERCOLATION TESTS AS REQUIRED FOR SEWAGE DISPOSAL FIELD. DESIGN SHOWN IS BASED ON A PERCOLATION RATE OF 10-20 MINUTES. DISPOSAL FIELD TO BE RESIZED AS REQUIRED.
  - EMBANKMENTS TO BE MAXIMUM SLOPE 2H:1V. TREAT WITH 150mm TOPSOIL AND NURSERY SOD.
  - CONTRACTOR SHALL ENSURE POSITIVE DRAINAGE AWAY FROM ALL PERIMETER LOCATIONS AT LIMITS OF SITE DEVELOPMENT. PROVIDE DRAINAGE SWALES AS AND WHERE REQUIRED.
  - SUPPLY AND INSTALL GUIDERAIL WHERE INDICATED ON DRAWING C1. PROVIDE 200X200 PRESSURE TREATED POSTS WITH 1200mm MIN BURY. PROVIDE TERMINAL SECTIONS AS SHOWN.


LEGEND	
[XXX.XX]	PROPOSED GRADES
~>	FLOW DIRECTION



NO.	DESCRIPTION	DATE	BY
0	ISSUED FOR TENDER	14/04/08	D.P.

REVISIONS

A	A - PLAN, SECTION, ELEVATION, OR DETAIL NO.
B	B - NO. OF DRAWING WHERE ABOVE IS DRAWN

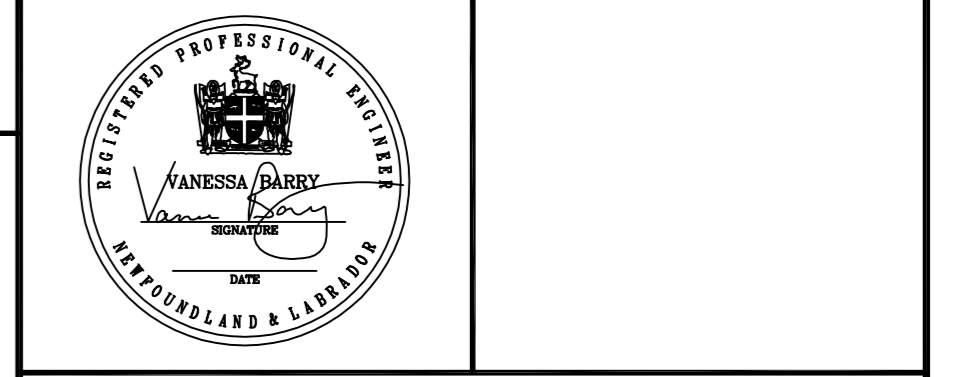

PRIME CONSULTANT

**CBCL LIMITED**  
Consulting Engineers  
187 KENMOUNT ROAD  
ST. JOHN'S, NL, A1B 4A4  
Phone: (709) 364-8623  
Fax: (709) 364-8627

SUB-CONSULTANT

AE Consultants Ltd  
ARCHITECTURE ENGINEERING  
341 Freshwater Rd., Suite 202  
PO Box 13156  
St. John's, NL, A1B 4A4  
Tel: (709) 726-1342  
Facsimile: (709) 726-1349  
email: admin-aecst@afid.net  
www.aecconsultants.ca

PROJECT  
**CONSTRUCT NEW TRANSPORTATION DEPOT  
CARTWRIGHT JUNCTION**  
CARTWRIGHT NEWFOUNDLAND LABRADOR

DRAWING  
**PROPOSED SITE PLAN**

DRAWN BY D.P.	CHECKED BY V.B.	APPROVED BY R.W.
PROJECT NO. 500705006	DWG. FILE NO.	FILE NO.
DATE APRIL 2008	SCALE 1:250	DRAWING NO. C1 REV. R0